




1 SUBSTATION BUILDING 1 (GEL)
1 : 100

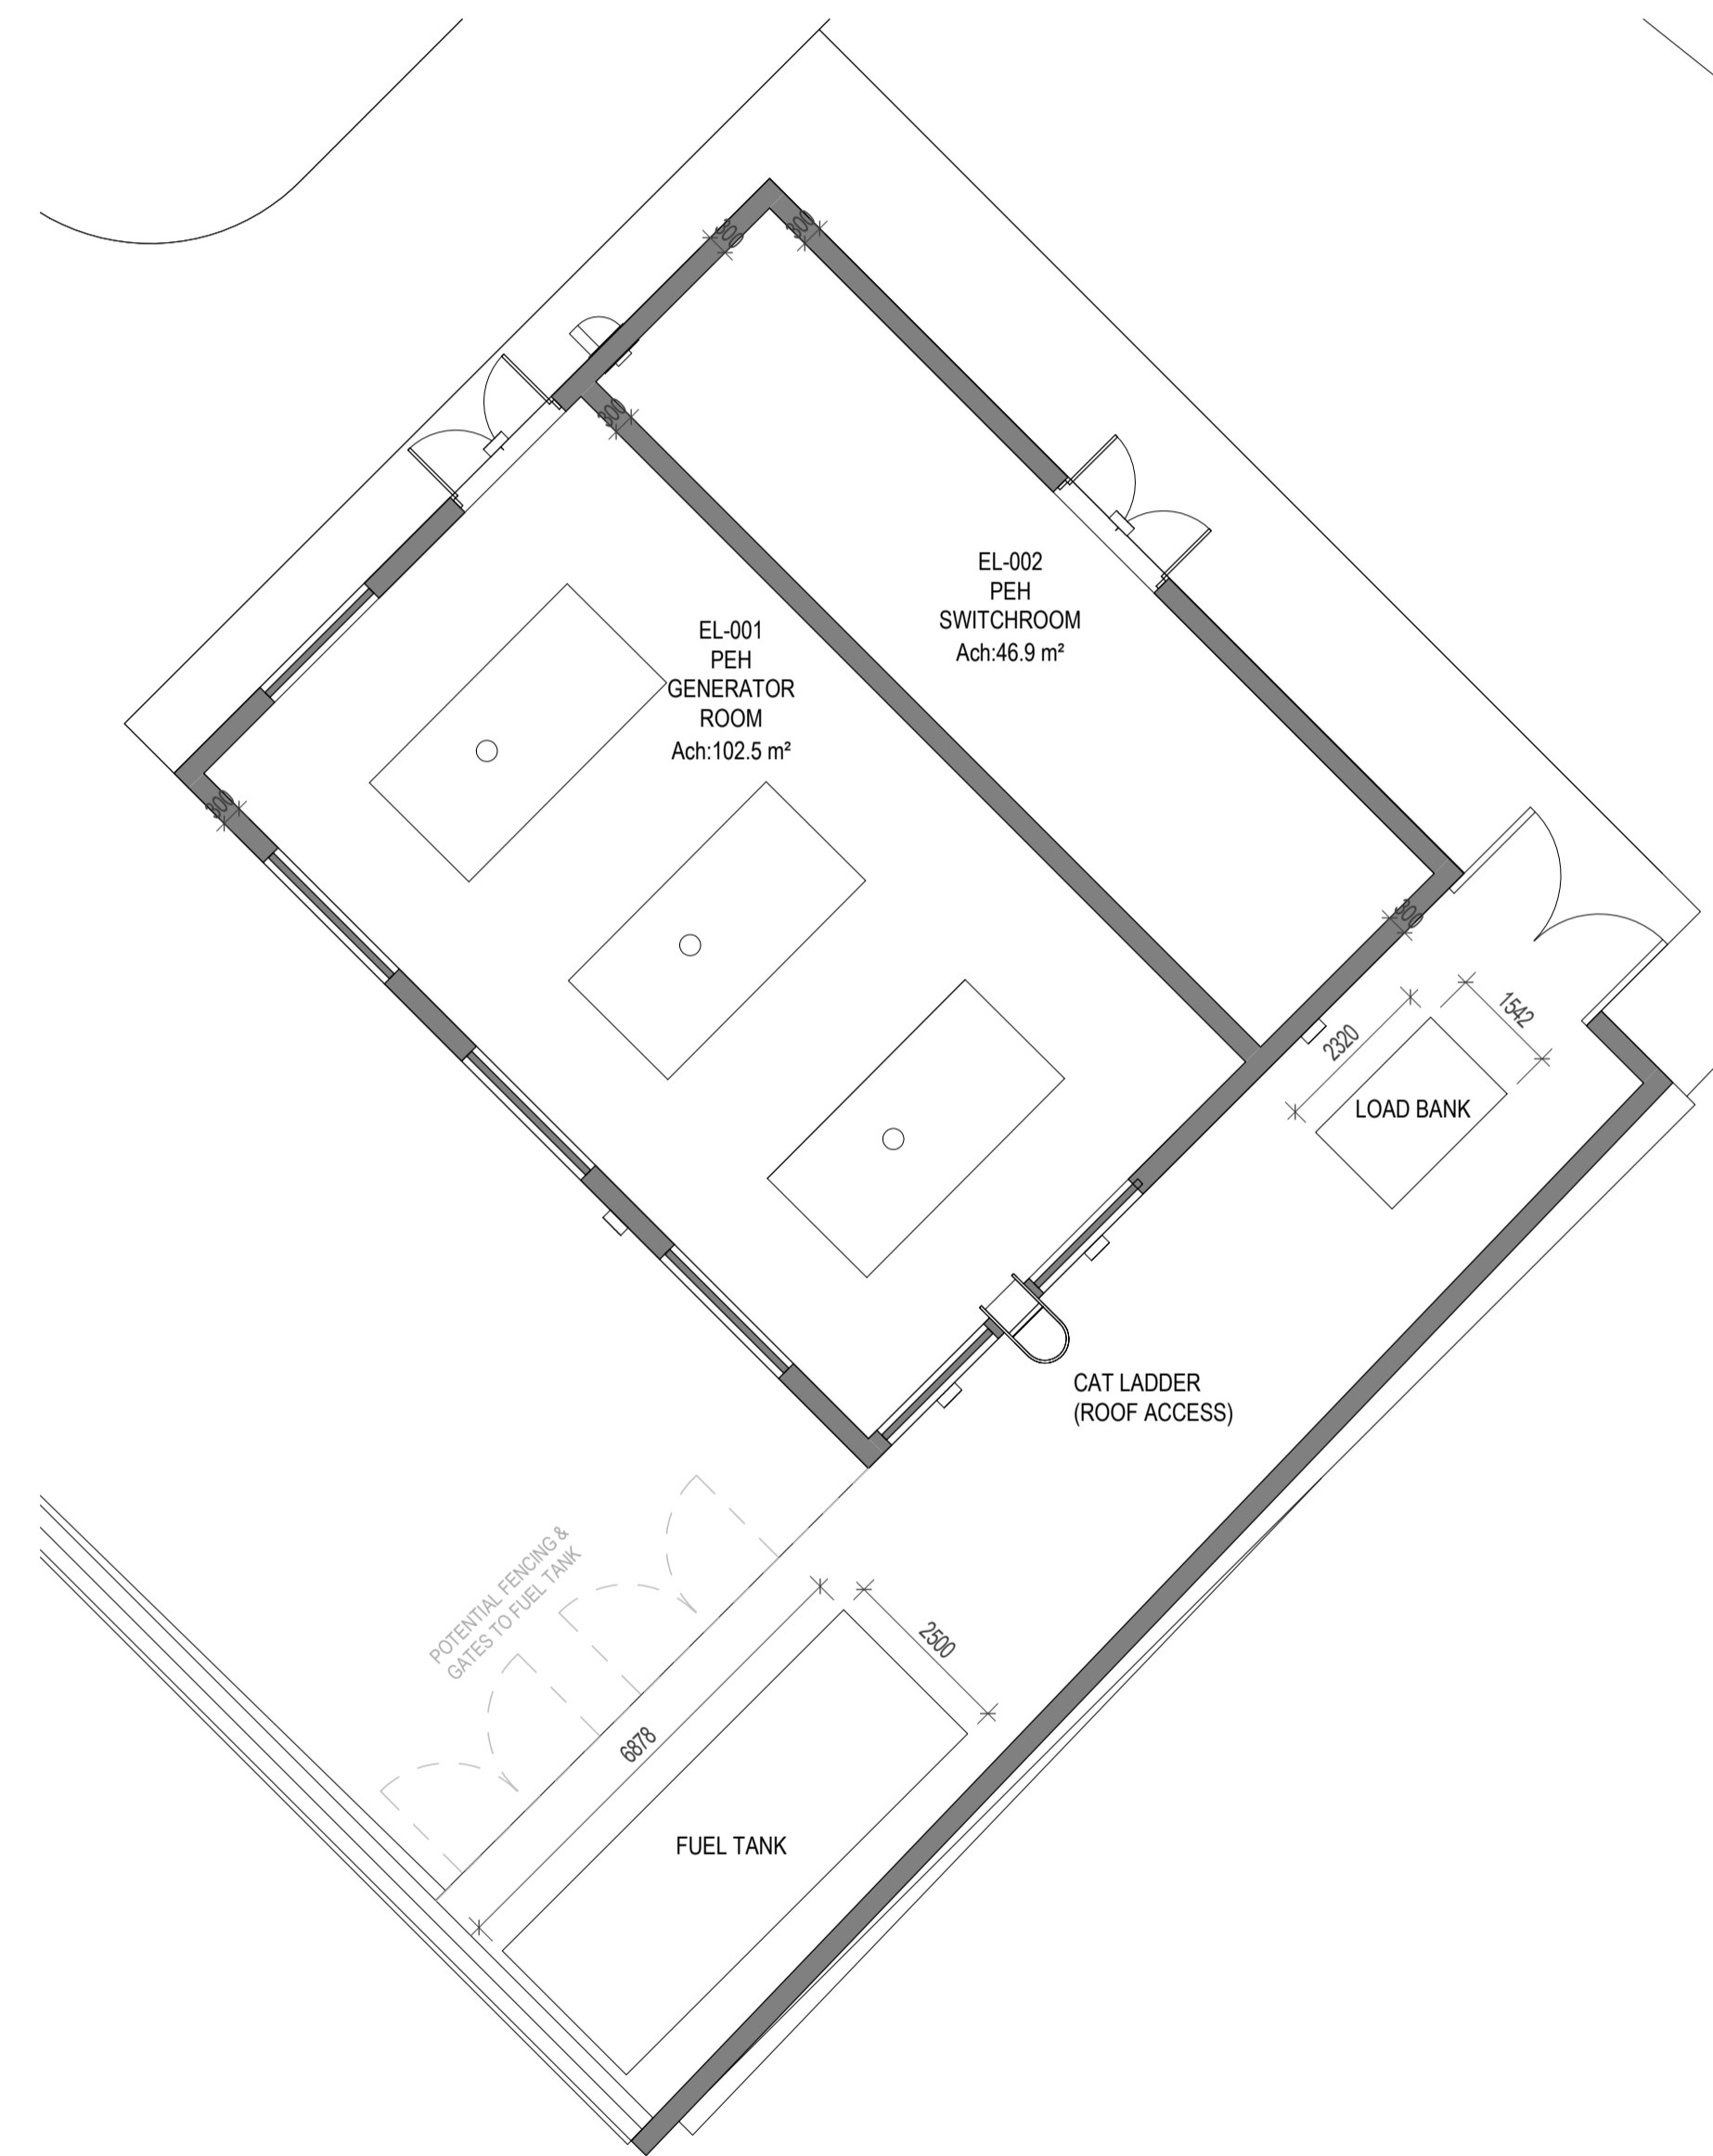

2 SUBSTATION BUILDING 2 (PEH)
1 : 100

Notes:

- This drawing is copyright.
- Do not scale dimensions from this drawing.
- This drawing is to be read in conjunction with all other relevant drawings.
- All discrepancies on this drawing are to be reported to the architect.
- Do not modify any element of this drawing.
- Use drawing only for purpose(s) issued.
- This drawing may contain colour.

Scale Bar
0 1m 3m 5m
Scale: 1:100

North Point
N

Key Plan
NOTE: PLEASE REFER TO DRAWING 123180-IBI-WS-ZZ-PL-A-200-0100 FOR BLOCK PLAN LAYOUT.

Hazard

	HAZ-xx To warn of significant hazards or information that is unusual To be read in conjunction with all other consultant's information Refer to CDM Schedule 123180-IBI-P2-XX-SH-A-800-0001
--	---

The following external model files are included within this drawing:

P1	29/01/2021	Issued for Planning	VS	AS
Rev	Date	Revision Notes	Drawn	Review

Logos

IBI Intelligence Buildings Infrastructure
www.ibigroup.com

Project
PEH Guernsey

Drawing Title
ELECTRICAL INFRASTRUCTURE WORKS
PROPOSED FLOOR PLANS

Job Number 123180	Date 29/01/21	Security Classification OFFICIAL	Drawn By VS
Scale@A1 1 : 100	Purpose PLANNING	Reviewed By AS	
Drawing Number 123180-IBI-WS-ZZ-PL-A-200-0106	Revision P1	Subsidiary S2	